

STRUCTURAL

CLARK DIETZ
118 S CLINTON, SUITE 700
CHICAGO, IL 60661
312.466.8242 (O)
DESIGN FIRM REGISTRATION
NO. 184-000450

M.E.P.

CLARK DIETZ
118 S CLINTON, SUITE 700
CHICAGO, IL 60661
312.466.8242 (O)
DESIGN FIRM REGISTRATION
NO. 184-000450

CIVIL

CLARK DIETZ
118 S CLINTON, SUITE 700
CHICAGO, IL 60661
312.466.8242 (O)
DESIGN FIRM REGISTRATION
NO. 184-000450

NOT FOR CONSTRUCTION

FOR REVIEW ONLY

Not for regulatory approval, permit or construction.

The information on this document is preliminary or incomplete, not for construction, recording purposes, or implementation.

ISSUANCE		
NO	DATE	DESCRIPTION
2	12/12/2024	ADDENDUM 2

**LAKE COUNTY PUBLIC WORKS
OFFICE ADDITION**
LAKE COUNTY, IL
650 WEST WINCHESTER ROAD,
LIBERTYVILLE, IL 60048
95% CD ISSUANCE

FIRST FLOOR PLUMBING FOUNDATION PLAN

SHEET NO.
P2.0


JOB NO. 24-4020.01
© 2024 FGM Architects Inc.

NOTES (THIS SHEET)

1. REFER TO SHEET A0.00 FOR GENERAL NOTES, LEGEND, AND ABBREVIATIONS.

KEYNOTES (THIS SHEET)

1. EXISTING 6" CW SERVICE BELOW SLAB TO REMAIN.
2. EXISTING SAN PIPING TO REMAIN.
3. EXISTING FLOOR DRAIN TO REMAIN.
4. EXISTING V PIPING TO REMAIN.
5. EXISTING SAN UP TO EXISTING MB TO REMAIN.
6. EXISTING SAN PIPING UP TO ABOVE SLAB TO REMAIN.
7. NEW SAN PIPING BELOW SLAB.
8. NEW SAN PIPING UP TO ABOVE SLAB. ROUTE PIPING IN NEW CHASE.
9. NEW SAN PIPING UP TO WC. ROUTE PIPING IN NEW CHASE.
10. NEW SAN PIPING UP TO CO.
11. NEW SAN PIPING UP TO FD.
12. NEW V PIPING UP TO ABOVE CEILING. ROUTE PIPING IN NEW CHASE.
13. NEW V PIPING UP ABOVE SLAB. CONNECT TO NEW EXTENDED VENT RISER AT LEAST 16" A.F.F.

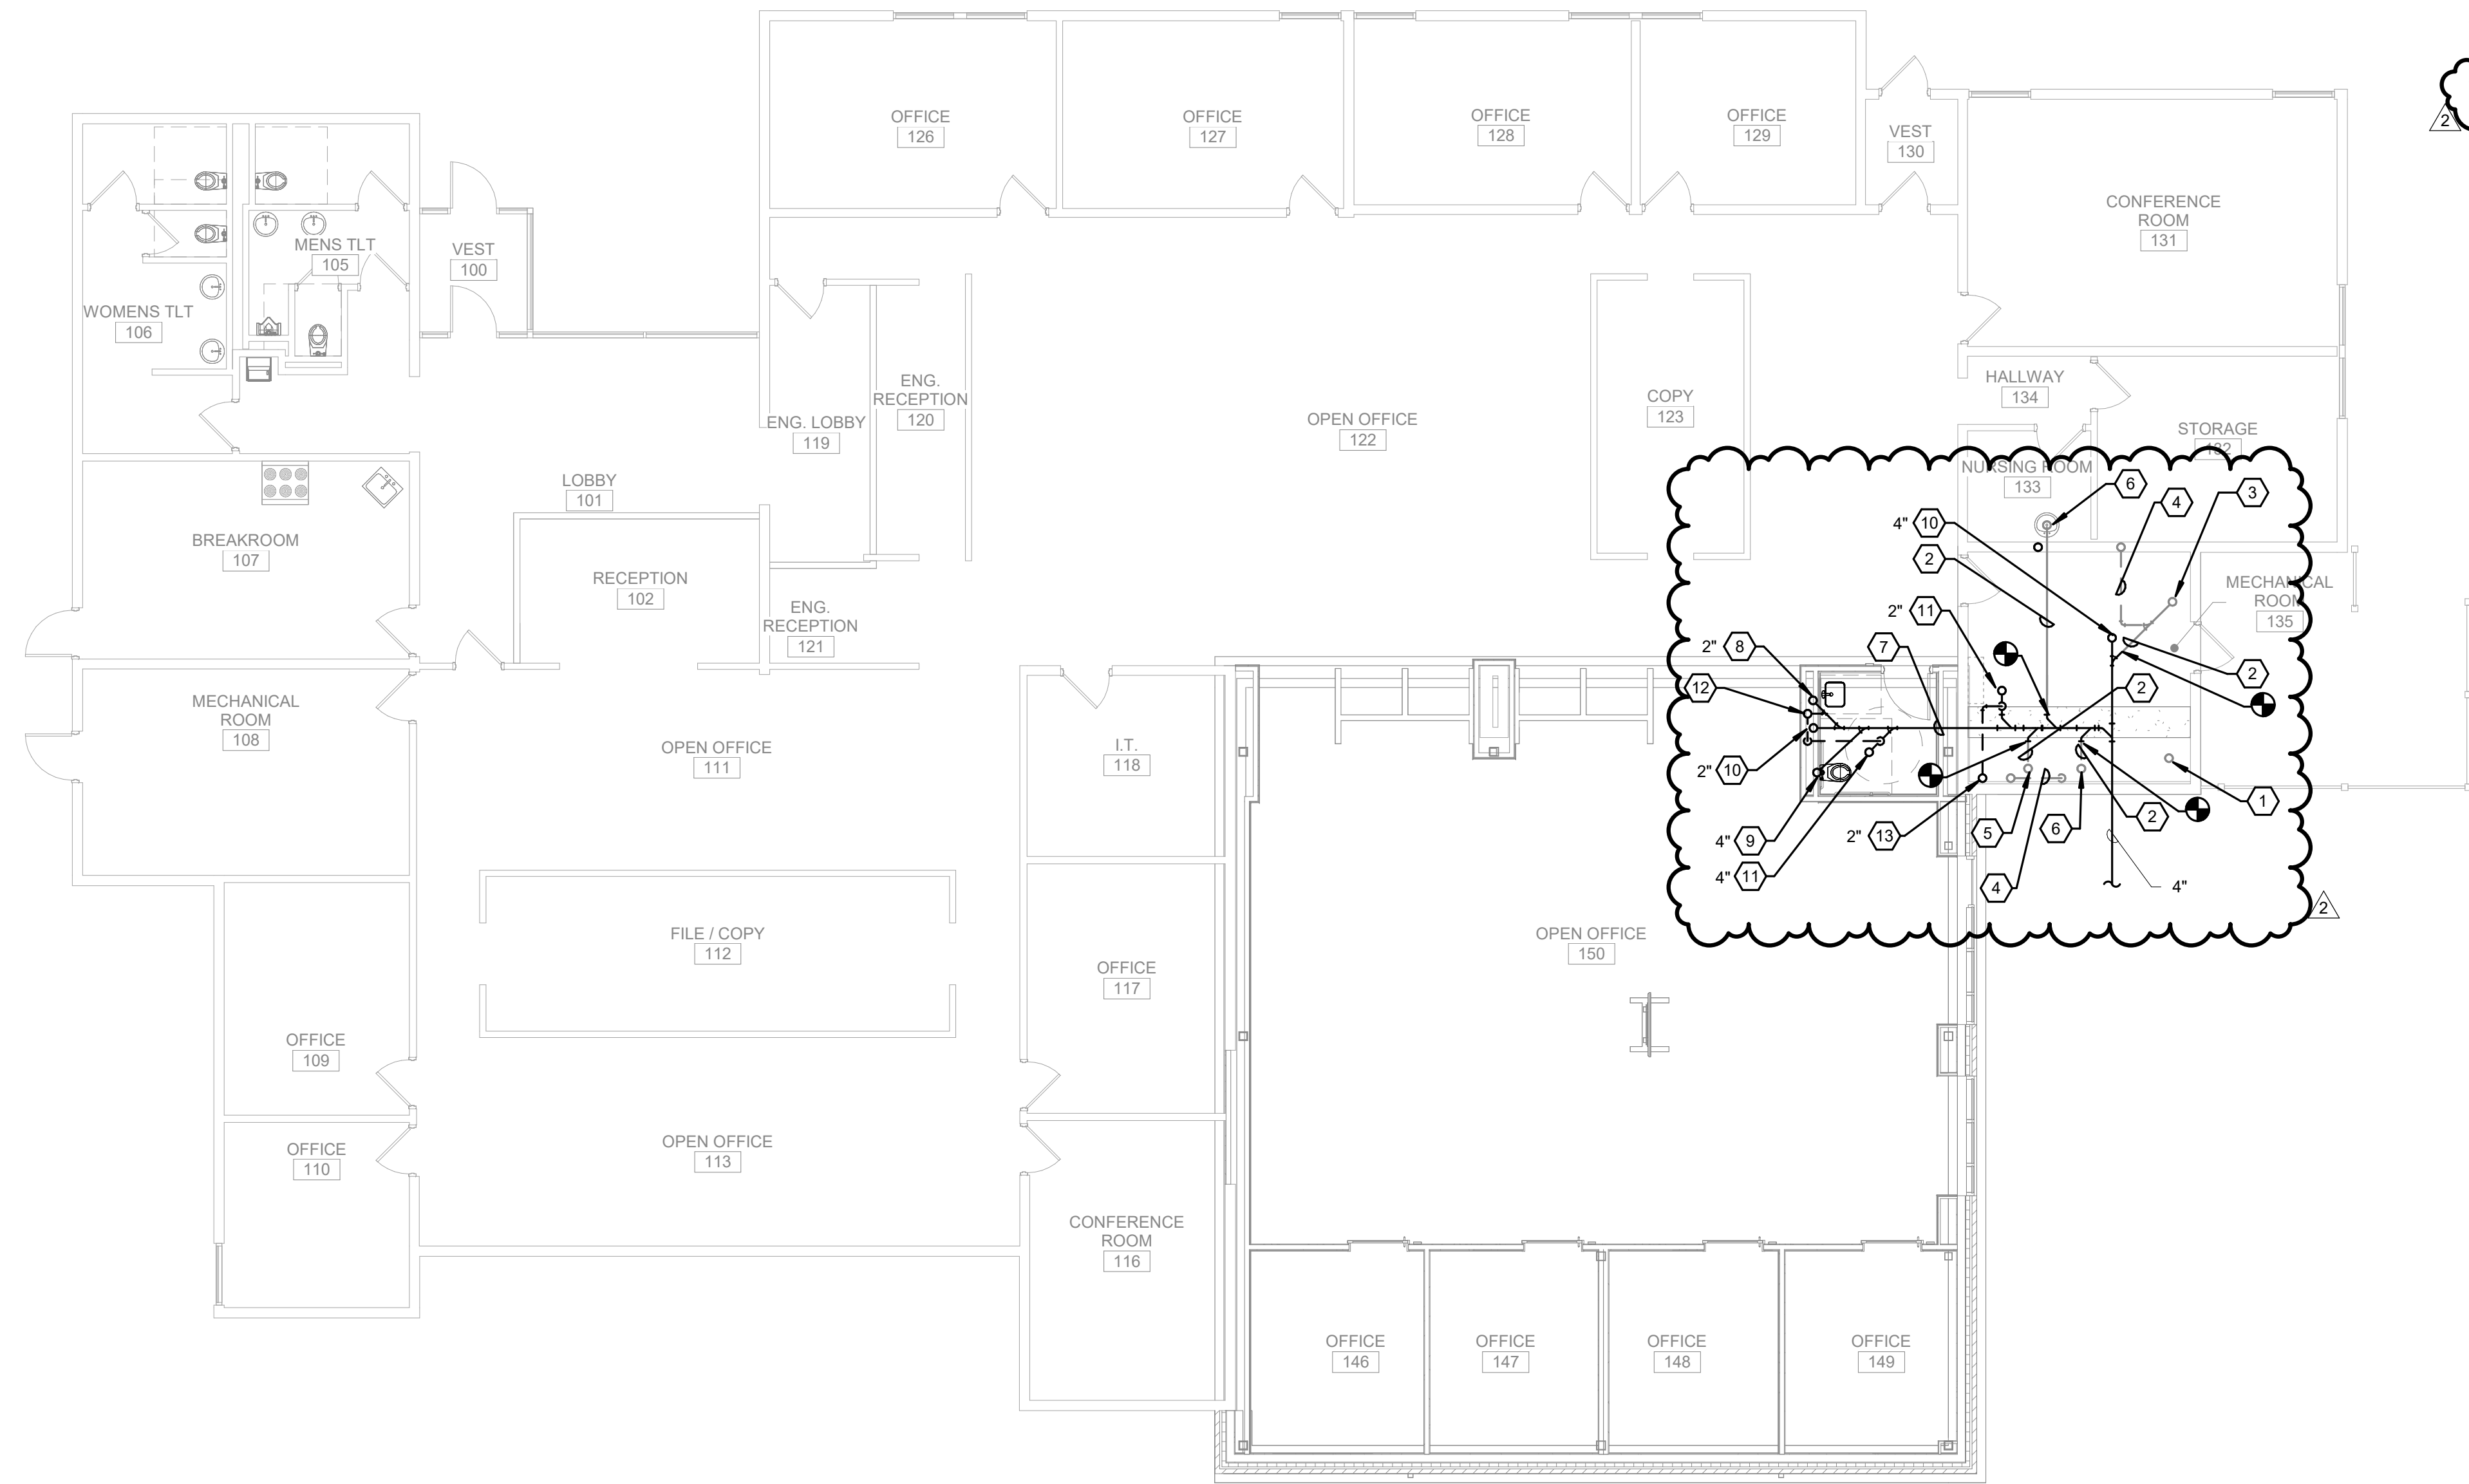

1 FIRST FLOOR PLUMBING FOUNDATION PLAN

